
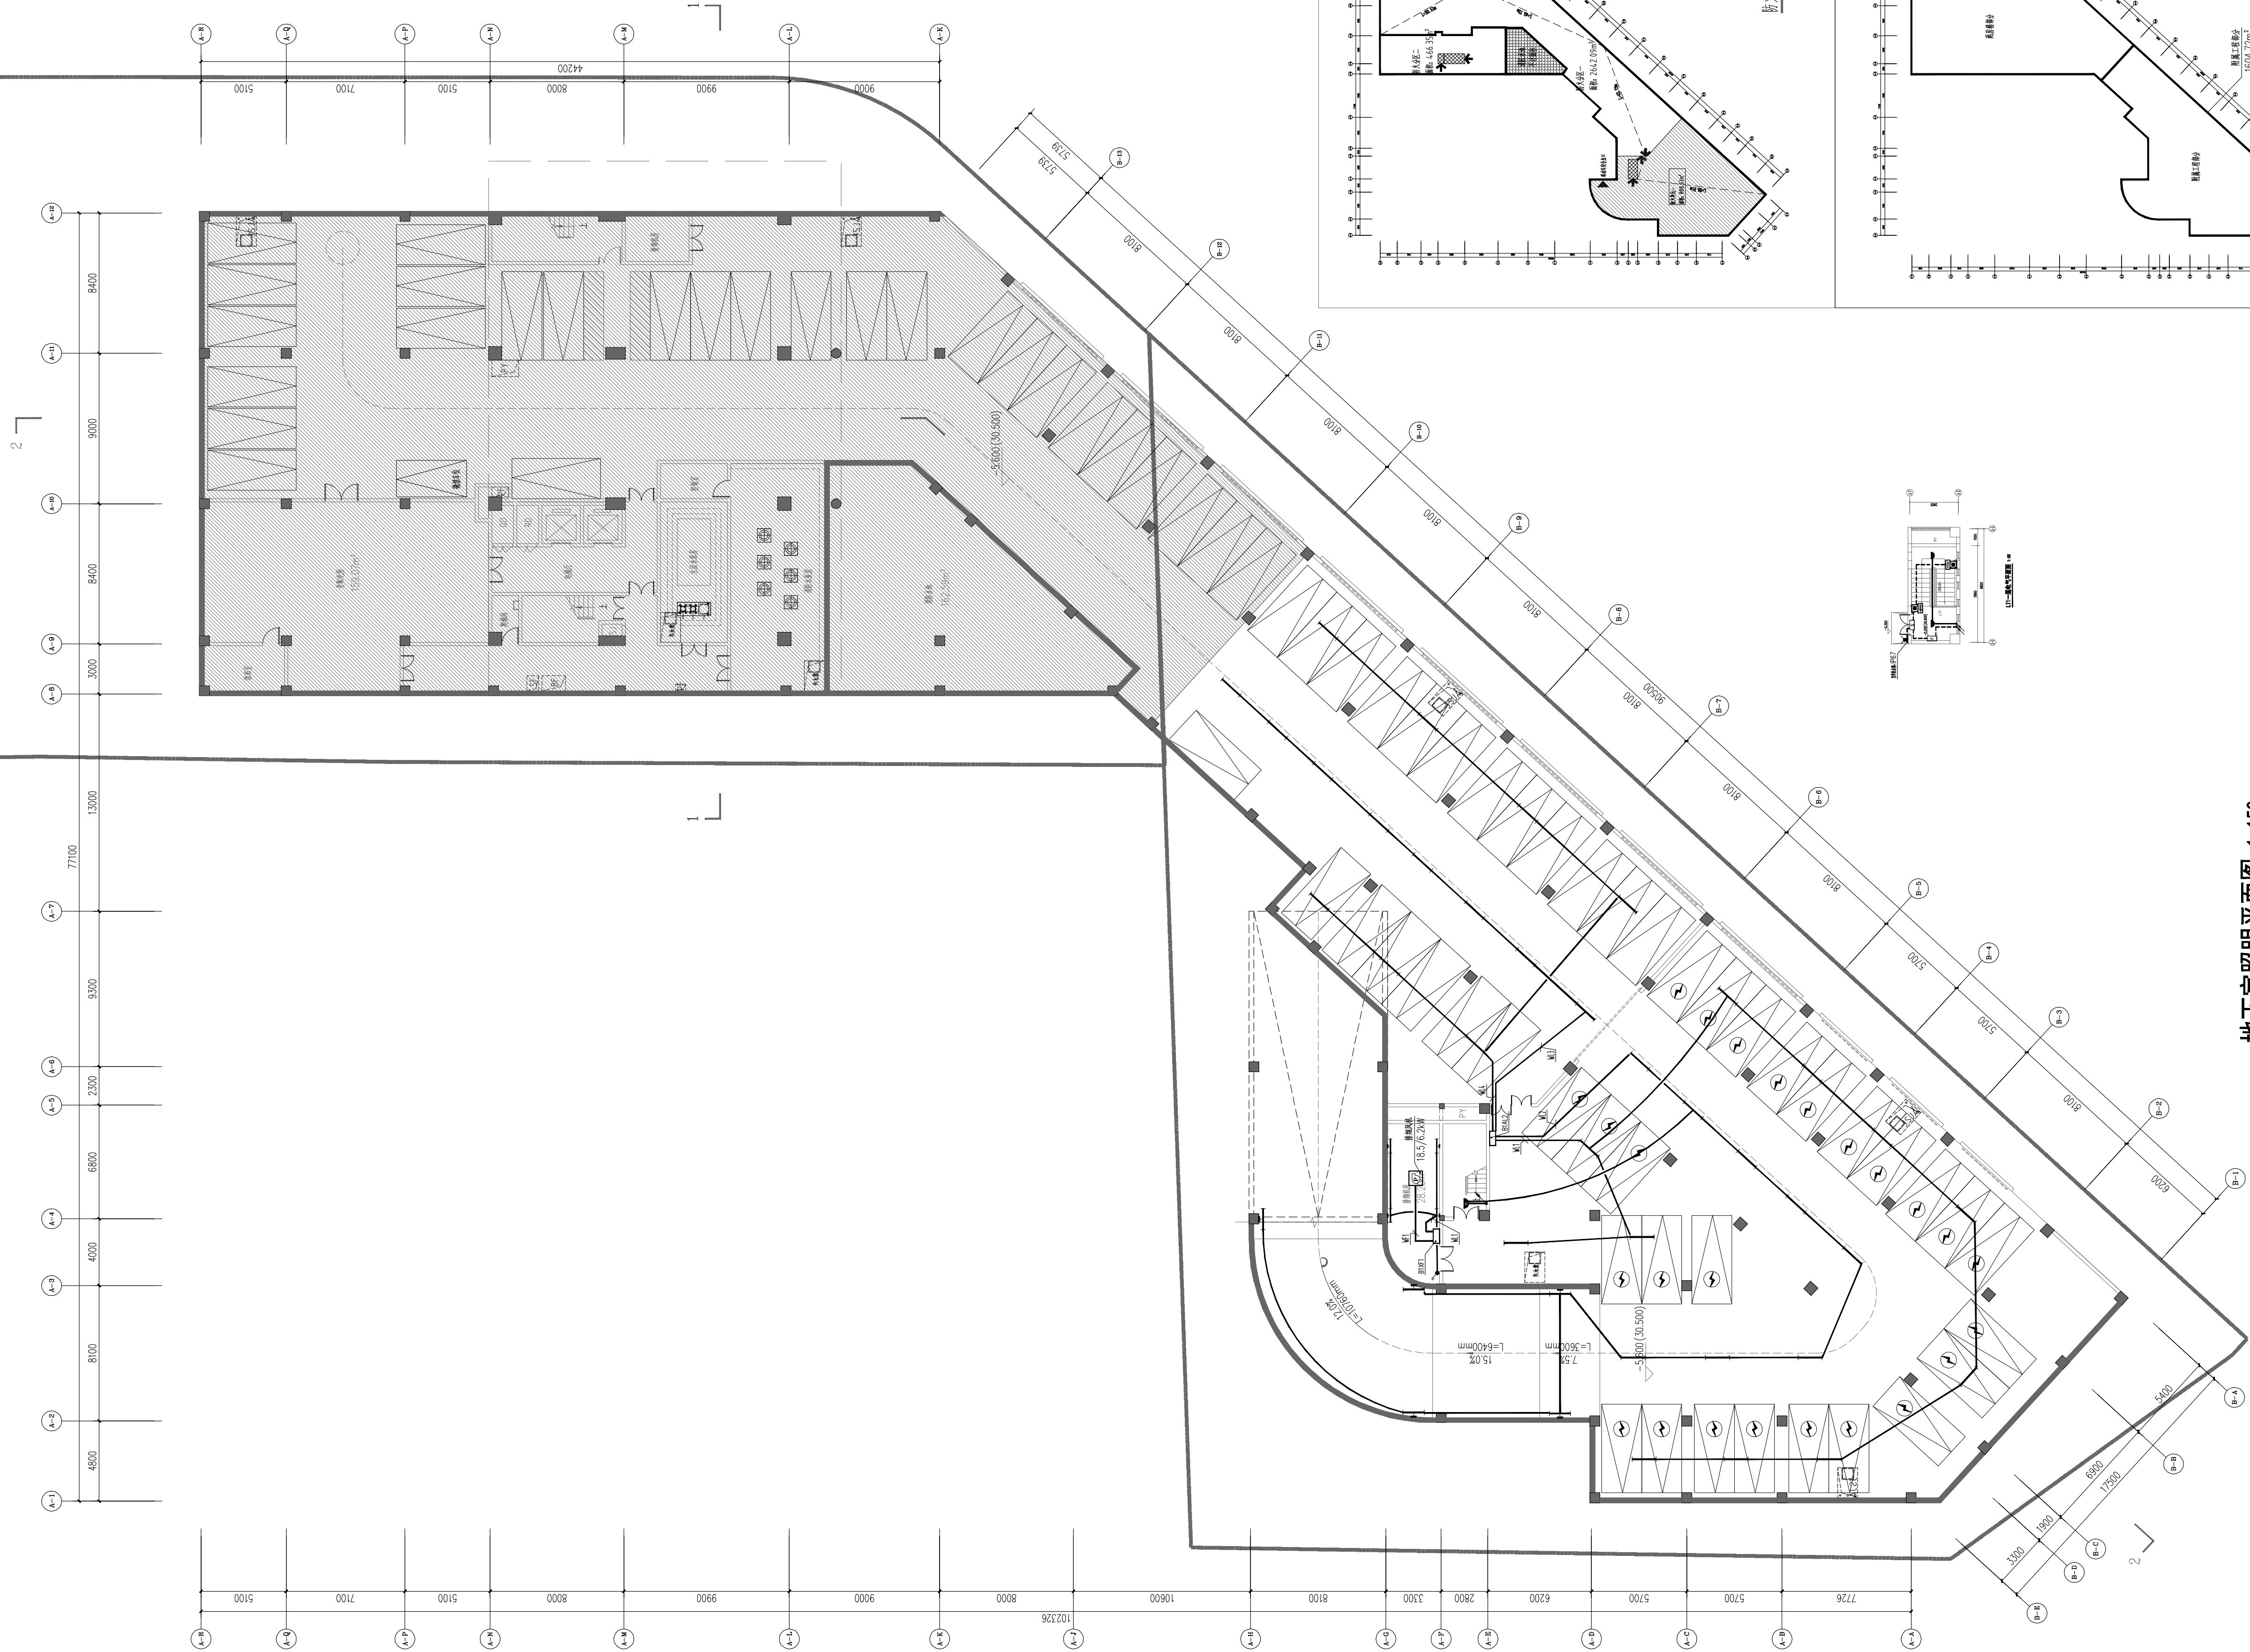



[illegible][illegible]

序号	图例	名称	单位	备注
1		圆孔 (100mm)	个	1330
2		圆孔 (100mm)	个	2200
3		圆孔 (100mm)	个	1500
4		圆孔 (100mm)	个	1500
5		圆孔 (100mm)	个	1500
6		圆孔 (100mm)	个	1500
7		圆孔 (100mm)	个	1500
8		圆孔 (100mm)	个	1500
9		圆孔 (100mm)	个	1500
10		圆孔 (100mm)	个	1500
11		圆孔 (100mm)	个	1500
12		圆孔 (100mm)	个	1500
13		圆孔 (100mm)	个	1500
14		圆孔 (100mm)	个	1500
15		圆孔 (100mm)	个	1500
16		圆孔 (100mm)	个	1500
17		圆孔 (100mm)	个	1500
18		圆孔 (100mm)	个	1500
19		圆孔 (100mm)	个	1500
20		圆孔 (100mm)	个	1500

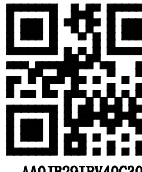

本图需加盖本司出图签章，否则一律无效

<div><div><div>湖南省建筑设计院集团股份有限公司</div><div>HUNAN ARCHITECTURAL DESIGN INSTITUTE GROUP CO.,LTD.</div></div></div>	
<div><div>设计证书甲级编号</div><div>A143000700</div><div>FIRST CLASS SERIAL NUMBER OF DESIGN CERTIFICATE: A143000700</div></div>	
<div><div>建设单位</div><div>CLIENT</div><div>岳阳市岳阳楼区人民</div></div>	
<div><div>工程名称</div><div>PROJ. NAME</div><div>岳阳市岳阳楼区人民</div></div>	
<div><div>子项名称</div><div>SUB-ITEM</div><div>岳阳市岳阳楼区人民</div></div>	
<div><div>设计签字</div><div>SIGNATURE</div><div><div><div>项目经理</div><div>PROJECT MANAGER</div><div>肖艺</div></div><div><div>设计总负责人</div><div>CHIEF DESIGNER</div><div>彭雨晴</div></div><div><div>专业负责人</div><div>SPE. DESIGNER</div><div>周良</div></div><div><div>设计</div><div>DESIGNER</div><div>周良</div></div><div><div>制图</div><div>DRAWER</div><div>周良</div></div><div><div>校对</div><div>CHECKED</div><div>熊晓江</div></div><div><div>审核</div><div>EXAMINED</div><div>陈珩</div></div><div><div>审定</div><div>APPROVED</div><div>龙海瑞</div></div><div><div>注册人</div><div>REGISTRANT</div><div></div></div></div></div>	
<div><div>出图盖章</div><div>STAMP</div><div></div></div>	
<div><div>图纸名称</div><div>DRAWING TITLE</div><div>地下室照明平面图</div></div>	
<div><div>工程代号</div><div>PROJ. NO.</div><div>2025-AB011</div></div>	<div><div>图别</div><div>D. S.</div><div>电施</div></div>
<div><div>版次</div><div>VER. No.</div><div>1.0</div></div>	<div><div>图号</div><div>D. NO.</div><div>013</div></div>
<div><div>日期</div><div>DATE</div><div>2025. 11</div></div>	